

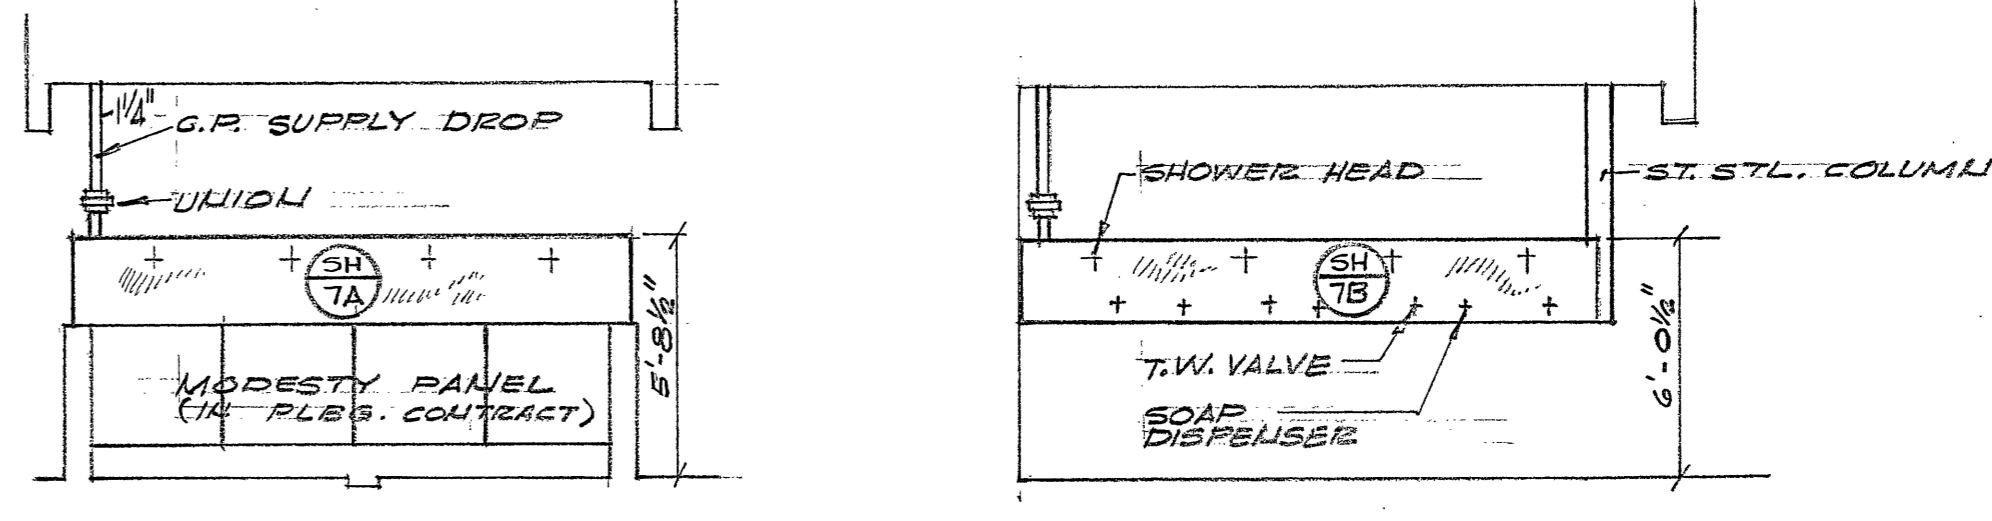


SECOND FLOOR PLUMBING PLAN
SCALE: 1/8" = 1'-0"

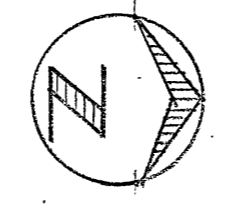

NOTE: SEE SHEET D-4-21 FOR ADDITIONAL INFORMATION.
WALL MTD. PANELS. SIMILAR-SEE PLANS FOR LOCATIONS.

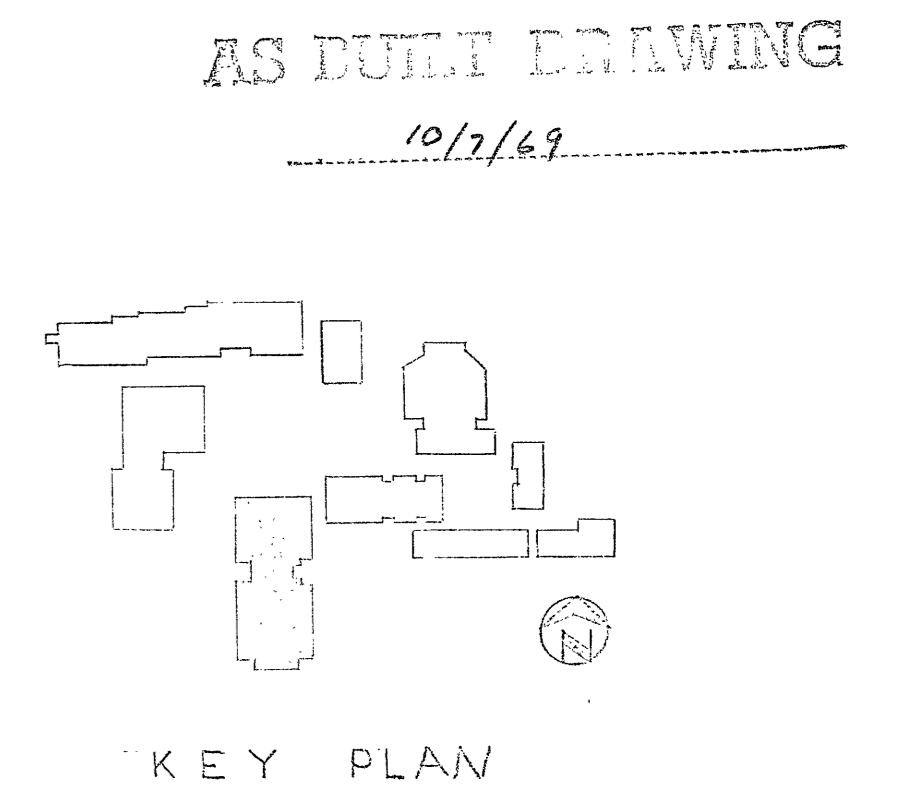

AS BUILT DRAWING
10/7/69

CONTRACTOR SHALL CHECK ALL DIMENSIONS AT THE JOB AND ACCEPT FULL RESPONSIBILITY FOR THEIR ACCURACY UNDER THE CONTRACT.

ENGINEERS	
STRUCTURAL	
CIVIL	
MECHANICAL	<i>Harpe & Bergquist</i>
ELECTRICAL	

APPROVALS:	
APPROVED STATE FIRE MARSHAL STATE OF CALIFORNIA DATE JUN 14 1966	APPROVED JUL 11 1966 JUL 11 1966
BY <i>[Signature]</i>	BY <i>[Signature]</i>

CLIENT APPROVAL	
DELEGATE BOARD OF EDUCATION <i>[Signature]</i>	APPROVED
PRINCIPAL <i>[Signature]</i>	
SUPERVISOR <i>[Signature]</i>	

REVISIONS		DESCRIPTION	APPROVED
NO.	DATE		
1	10/7/69	AS BUILT	

JOB NO. 614
DRAWN <i>JCB/USP</i>
TRACED
CHECKED <i>BRUCE</i>
ARCHITECT

SECOND FLOOR PLAN		GYMNASIUM BLDG. "D"	
GLENDALE HIGH SCHOOL DISTRICT 1460 EAST GARDWAY GLENDALE 2, CALIFORNIA			
ADRIAN WILSON and ASSOCIATES		ENGINEERS and PLANNERS	
816 WEST FIFTH STREET		LOS ANGELES 17, CALIFORNIA	

DRAWING NUMBER	D
P-2	
DATE	JUL 11 1966